


**ELECTEC EQUIPMENT LIST**

- Ⓜ INTERCEPTOR 100-\_\_\_-F1 . (\_\_\_=voltage)
- Ⓜ DUAL RECEPTACLE 100-\_\_\_-RRT . (\_\_\_=voltage)
- Ⓜ STARTER CABLE 101-\_\_\_-SCS [L] . (\_\_\_=voltage [L]=LENGTH)
- Ⓜ DROP CABLE 102-\_\_\_-JCS [L] . (\_\_\_=voltage [L]=LENGTH)
- Ⓜ JOINER CABLE 102-\_\_\_-JCS [L] . (\_\_\_=voltage [L]=LENGTH)
- Ⓜ SWITCHING INTERCEPTOR 103-\_\_\_-SWI . (\_\_\_=voltage)
- Ⓜ SWITCHING CABLE 104-\_\_\_-SWCS [L] . (\_\_\_=VOLTAGE [L] LENGTH)
- Ⓜ MULTI TAP 107-\_\_\_-TAP . (\_\_\_=VOLTAGE)
- Ⓜ DUAL RECEPTACLE \_\_\_-RR . (\_\_\_=31RR [normal power])
- Ⓜ DUAL RECEPTACLE \_\_\_-RR . (\_\_\_=41RR [isolated ground])
- Ⓜ RECEPTACLE BOX BX-Y-Z . (x=box size,y=quantity of recept.,z=dual recept. type)
- Ⓜ US=FEEDER STARTER \_C #\_\_\_+grd."ULTRALX-90 deg. ( \_C=# of conductors, #\_\_\_=size of conductors) c/w 60" & 8" wire tails
- Ⓜ UT=FEEDER \_C #\_\_\_+grd."ULTRALX-90 deg. ( \_C=# of conductors, #\_\_\_=size of conductors) c/w 8" & 8" wire tails
- Ⓜ ULTRALX-FLEX "Ux" (x=size of flexible conduit)to suit
- Ⓜ ARMoured CABLE SET "31MTbk20a" [L] c/w male cap & L.N.L.C. ([L]=LENGTH)
- Ⓜ ARMoured CABLE SET "41MTbk20a" (I.G.) [L] c/w male cap & L.N.L.C. ([L]=LENGTH)
- Ⓜ LOCK/UTLESS BOX CONNECTOR (L.N.L.C.)
- Ⓜ UNDER RAISED FLOOR BOX "B13"-Y-Z . ( y=quantity of recept.,z=dual recept. type)
- Ⓜ IN RAISED FLOOR BOX "WFB"\_\_\_[hinged cover](\_\_\_=per/1,q/ta/comm.outlets to suit)
- Ⓜ SINGLE RECEPTACLE 92R . (92R=phases A,B,C,3-N,2-I.G. & GRD. [isolated ground])
- Ⓜ MALE PLUG 92MT \_\_\_[L] (L=length,92MT=phases A,B,C,3-N & 2-I.G. & GRD. [isolated ground])

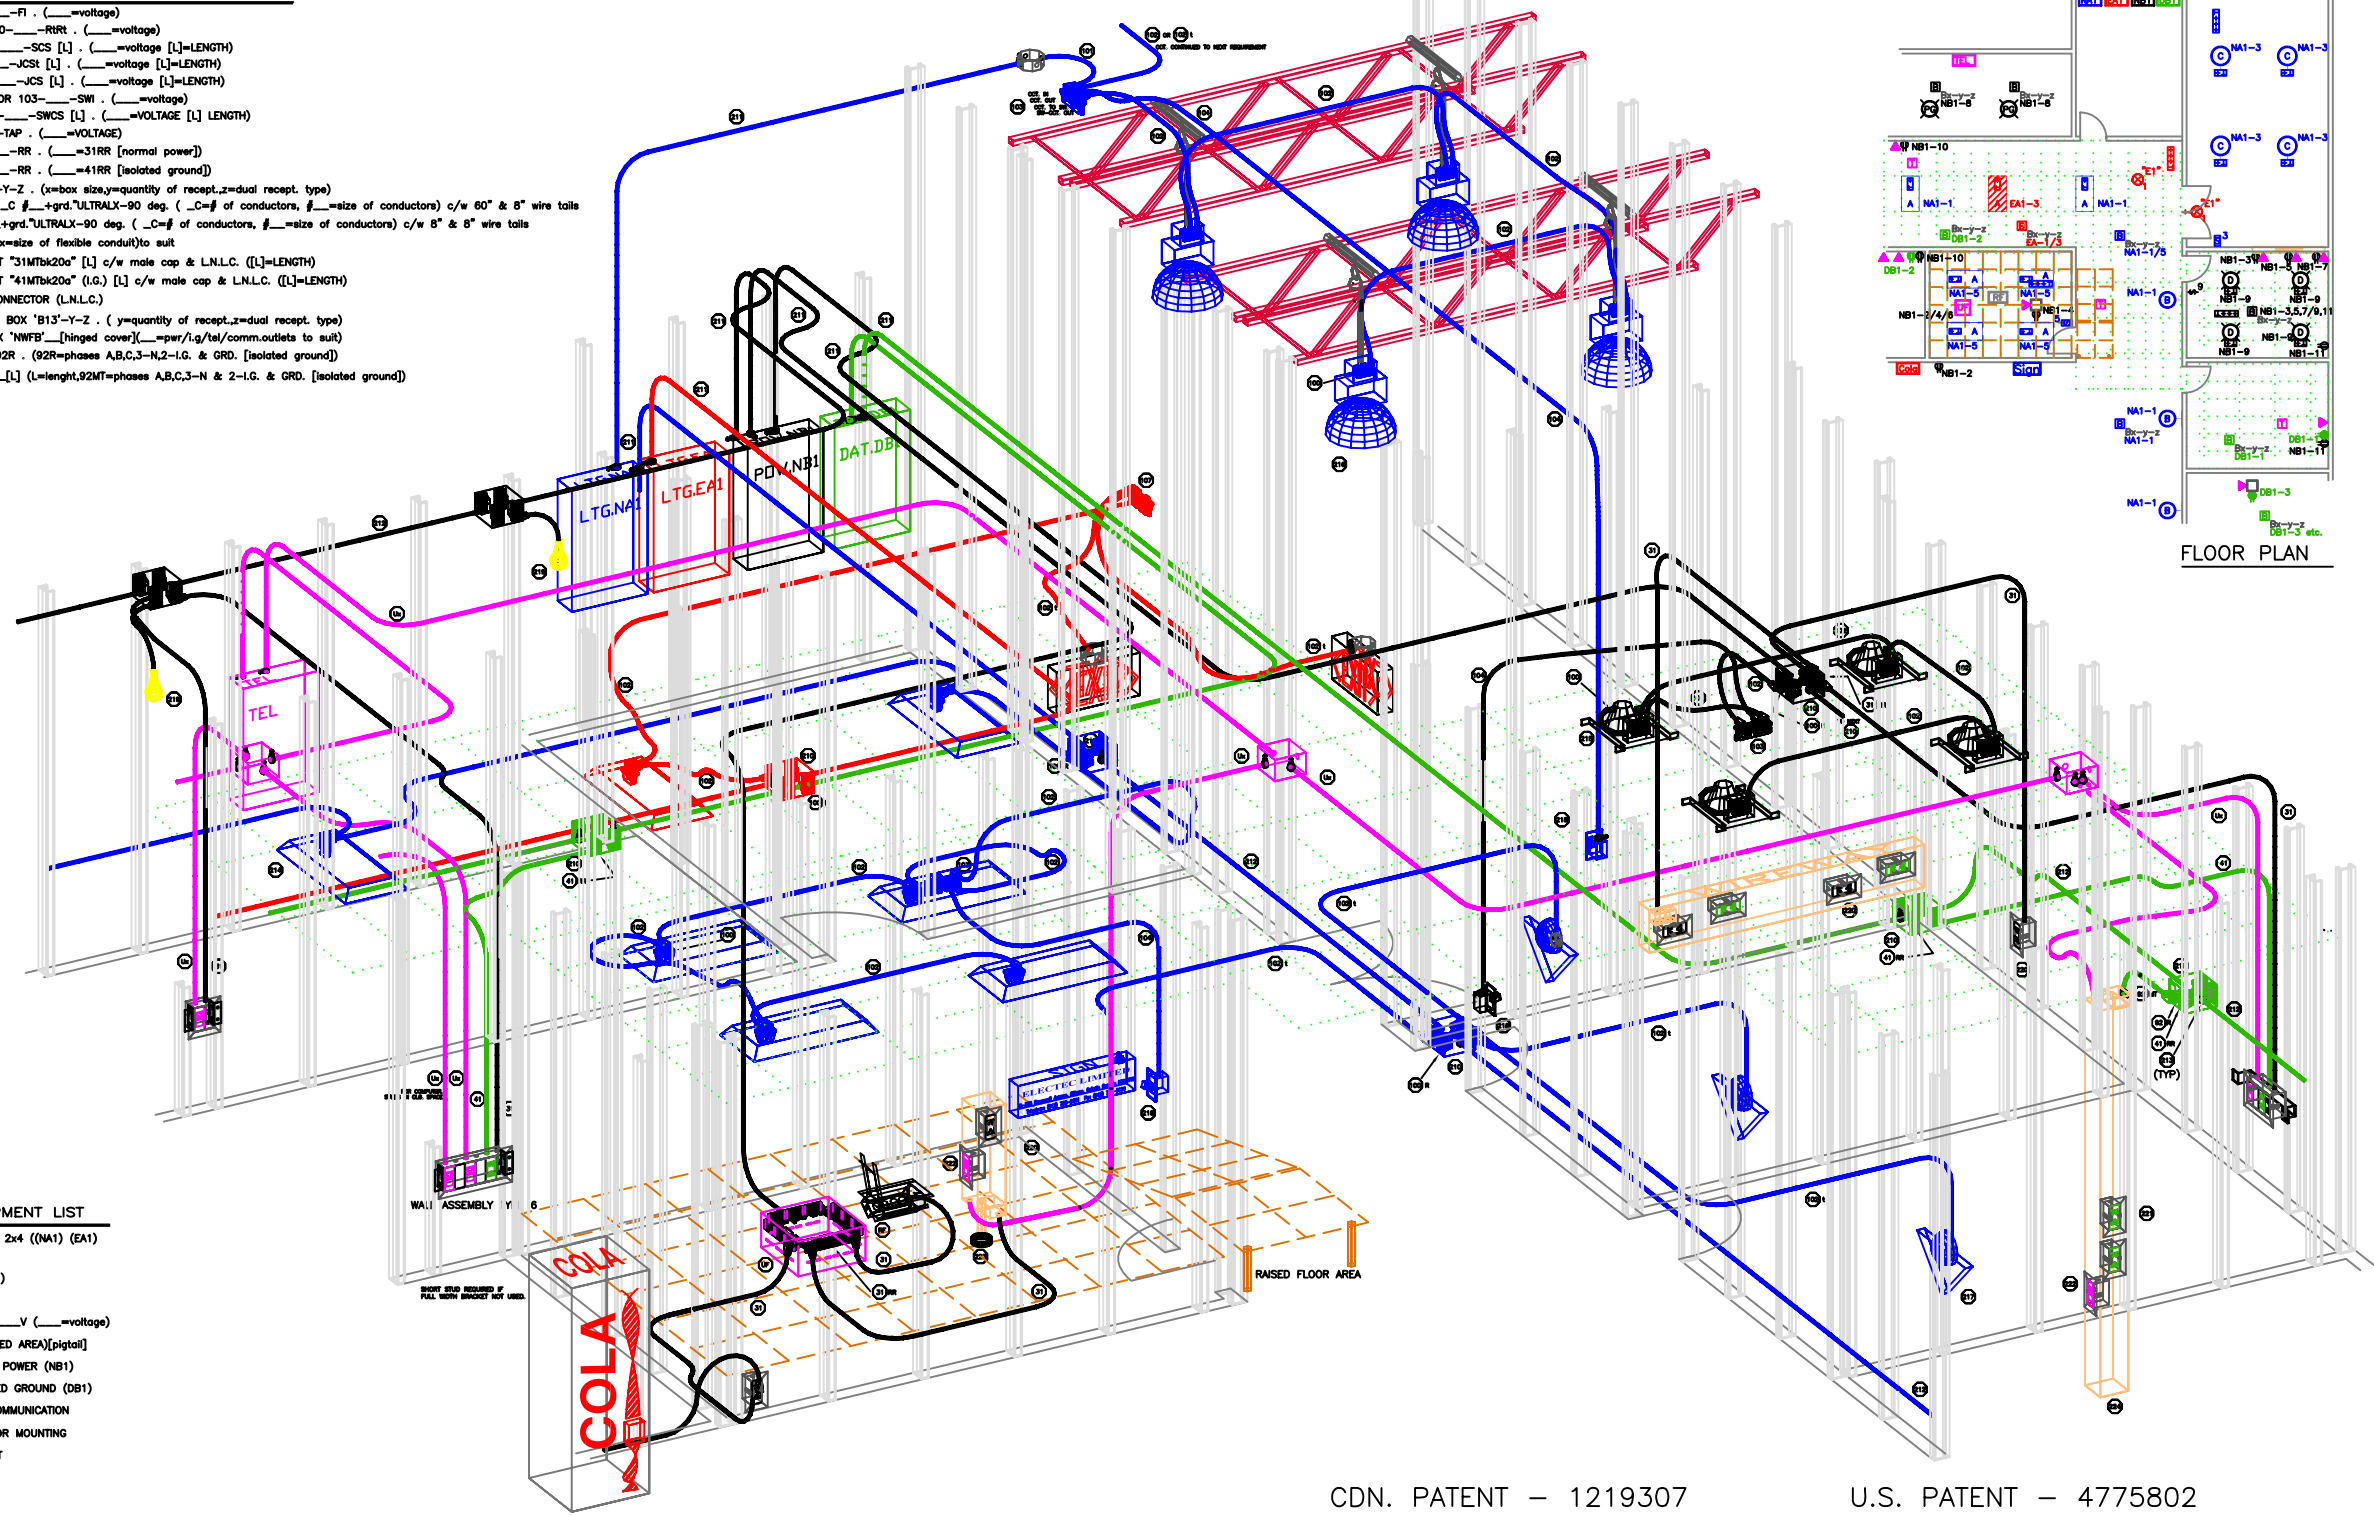

**ELECTRICAL EQUIPMENT LIST**

- Ⓜ FLUORESCENT FIXTURE 2x4 (NA1) (EA1)
- Ⓜ POT LIGHT (NB1)
- Ⓜ HIGHBAY FIXTURE (NA1)
- Ⓜ WALLSCONE (NA1)
- Ⓜ SINGLE POLE SWITCH \_\_\_V (\_\_\_=voltage)
- Ⓜ TEMP.FIXTURE(UNFINISHED AREA)[pigtail]
- Ⓜ OUTLET 120V NORMAL POWER (NB1)
- Ⓜ OUTLET 120V DEDICATED GROUND (DB1)
- Ⓜ OUTLET TELEPHONE/COMMUNICATION
- Ⓜ PEDESTAL RAISED FLOOR MOUNTING
- Ⓜ PEDESTAL FULL HEIGHT

CDN. PATENT - 1219307

U.S. PATENT - 4775802

ITEM	DESCRIPTION	MANUFACTURER	PART#/POSITION	REMARKS
	BLACK 125V NORMAL			
	RED 125V EMERGENCY			
	BLUE 347V NORMAL			
	RED 347V EMERGENCY			
	ORANGE LOW VOLTAGE			
	LIGHT GREEN L.V.BALAST CABLES			
	GREEN 125V DATA			
	PURPLE COMMUNICATION			
	CYAN B.A.S.			



"SMART<>CONNECT", "SMART LIGHT" & "ULTRALX" are trade marks of **ELECTEC LIMITED**.  
www.electeconline.com

OWNERSHIP OF DOCUMENTS:  
This drawing and accompanying information as instruments of service are the property of **ELECTEC**.  
Reproduction or use in whole or in part in any form whether the work for which they are presented be executed or not is forbidden without the express written permission of **ELECTEC**.

SMART<>CONNECT  
ELECTRICAL LAYOUT

DRAWN BY: J.Y.	APPROVED: D.H.
DATE: 30-Apr-01	SCALE: N.T.S.

ELELAYOUT.0